


1
AW
1:100
ELECTRICAL PLAN - LEVEL 1

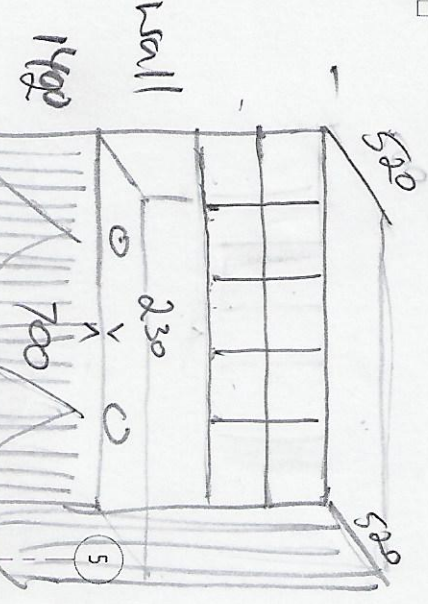

Timber cladding
 Thu 27.2.25
 For Tiger Installations for phone cables
 Contact Asher for drawing
 0417 286 967
 Down slot
 Timber cladding

6245
 6243

1400
 500

Bench seat 600
 1400 High
 Filters behind
 1400 High


199 High
 Commx Drawers
 Black

Timber cladding
 by Joe

16mm
 Black Melamine
 Timber cladding
 Plan View

holes for dirty towels

Excess to
 water filters
 about 20mm clear
 Drawers for wood
 Tenders for wood

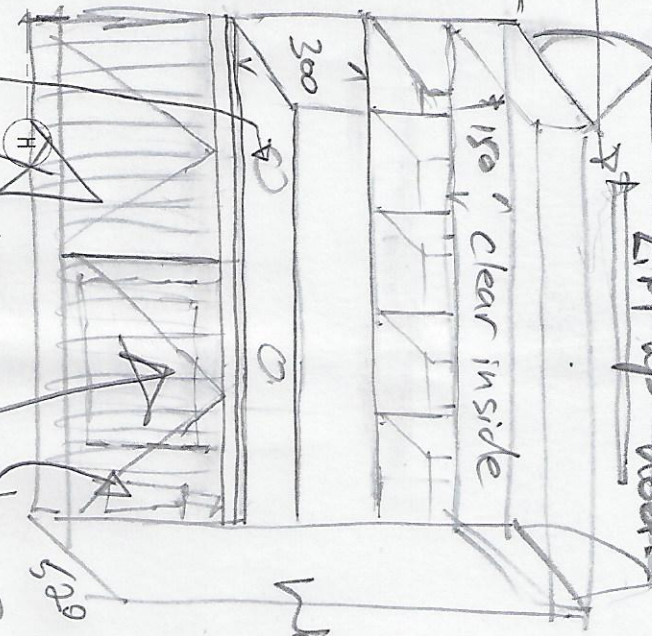

FOR INFORMATION
 NOTE TO CONTRACTORS
 * DO NOT SCALE DRAWINGS
 * ALL DIMENSIONS SHALL BE TAKEN IN PREFERENCE TO SCALE
 * VERIFY ALL DIMENSIONS ON SITE PRIOR TO COMMENCEMENT OF ANY WORKS OR START ANY DISBURSEMENTS SHALL BE REFERRED TO THE ARCHITECT
 * THIS DRAWING IS STRICTLY CONFIDENTIAL AND SHALL NOT BE COPIED, REPRODUCED, LENT, OR USED FOR ANY OTHER PURPOSES WITHOUT THE WRITTEN PERMISSION OF THE ARCHITECT
 * THIS DRAWING SHALL BE USED IN CONNECTION WITH THE SPECIFICATIONS AND CONTRACT DOCUMENTS AND SHALL BE USED IN CONNECTION WITH THE SPECIFICATIONS AND CONTRACT DOCUMENTS AND SHALL BE USED IN CONNECTION WITH THE SPECIFICATIONS AND CONTRACT DOCUMENTS

bg
architecture
 13 acacia drive, melbourne
 telephone: 03 9556 3300
 fax: 03 9556 4006
 email: info@bgarch.com.au
 www.bgarch.com.au
 victoria 3105 australia
 A/CN 11017
 1/11/2021 3:57:26 PM

Project
UNDFDD GYM LEVEL 1 /
620 CHURCH ST RICHMOND
 Level 1 620 Church Street, Richmond

drawing
ELECTRICAL PLAN - LEVEL 1

scale 1:100
 date
 issue date
 author
 checked
 drafter
 job number 24.20
 drawing number A400
 job date 4/7/2021 3:57:26 PM

| REV | DATE | DETAILS | INT |
|-----|------------|-------------------|-----|
| 01 | 04.07.2021 | ISSUED FOR TENDER | |